



DRAINAGE PLAN 1: 100

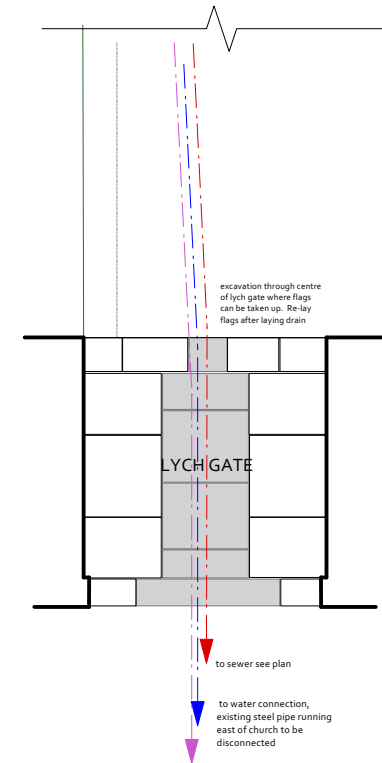

SEWER CONNECTION PLAN 1: 1250

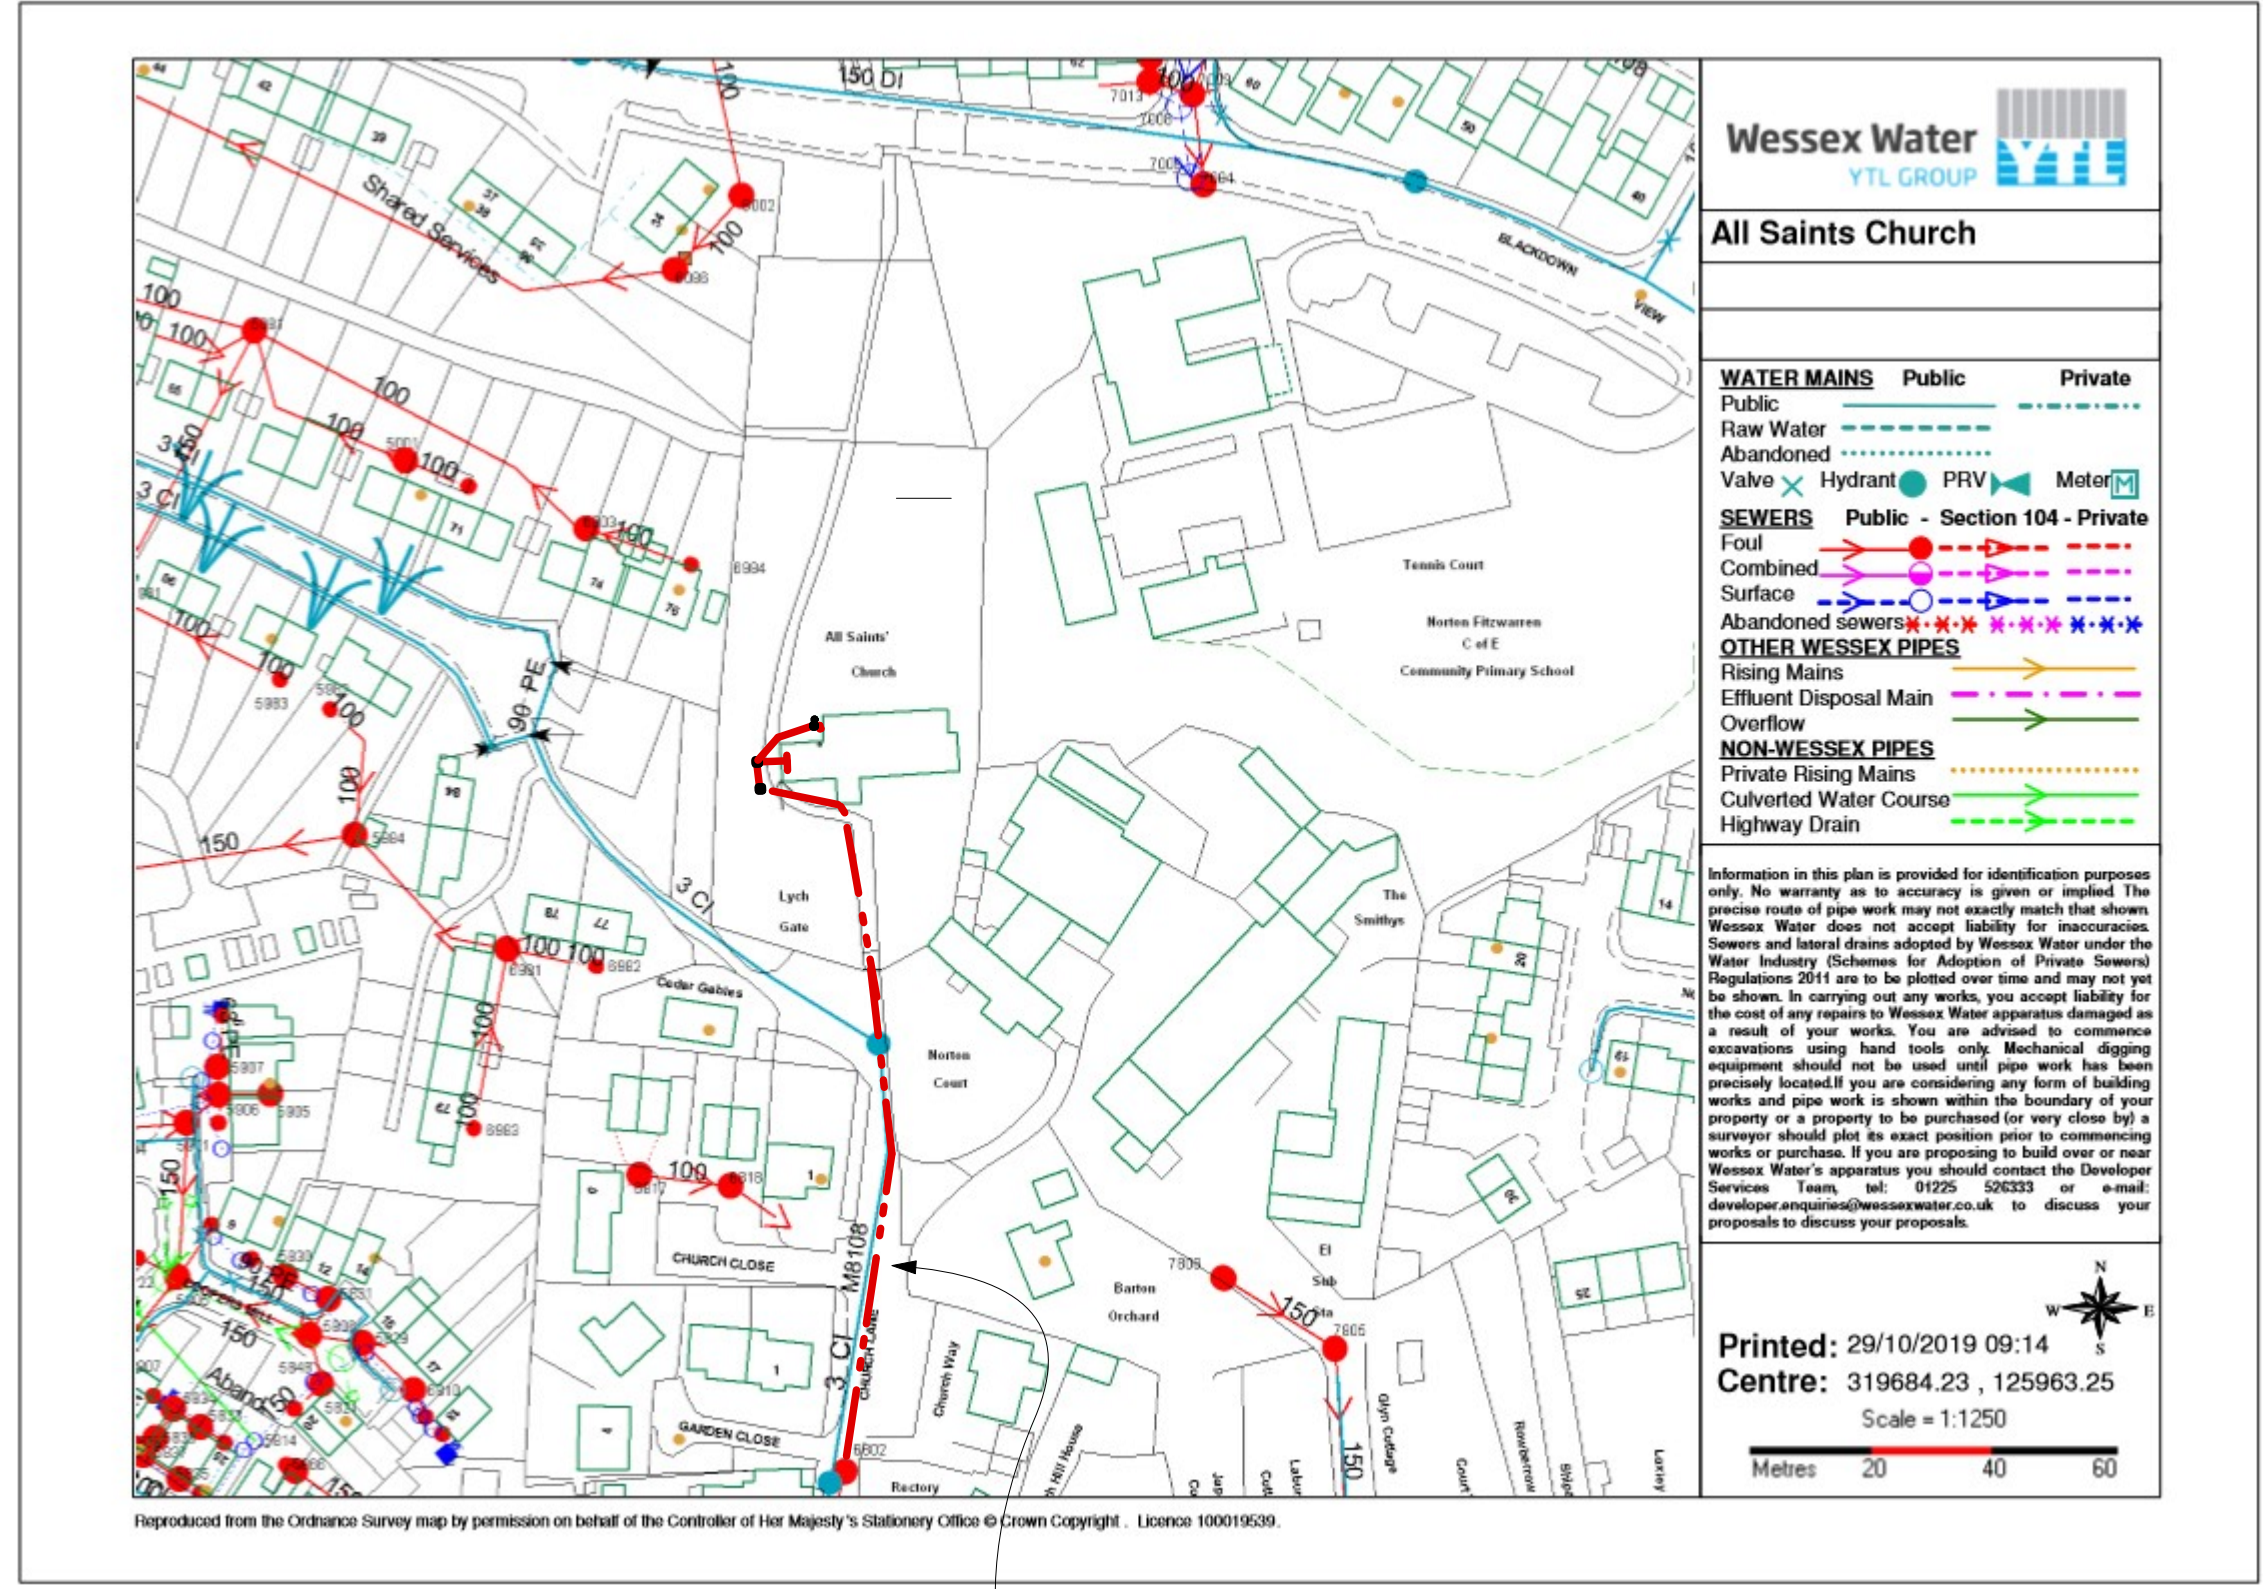

new drain laid through churchyard connection into manhole or saddle by Wessex Water

Annie Evans architect

Job NORTON FITZWARREN ALL SAINTS
Drawing Lavatory proposals Services plan
Number 237.13A
Scale 1:100 and 1:1250 when printed at A2
Date March 2024
Revision: A door swings feb25

Sowdens
Fiddington
Bridgwater
TA5 1JH
tel 01278 732339
e-mail architecture@annie-evans.co.uk

Copyright of this drawing belongs to Annie Evans. It may not be reproduced, altered or issued for use without prior permission in writing.